


REVISIONS	BY

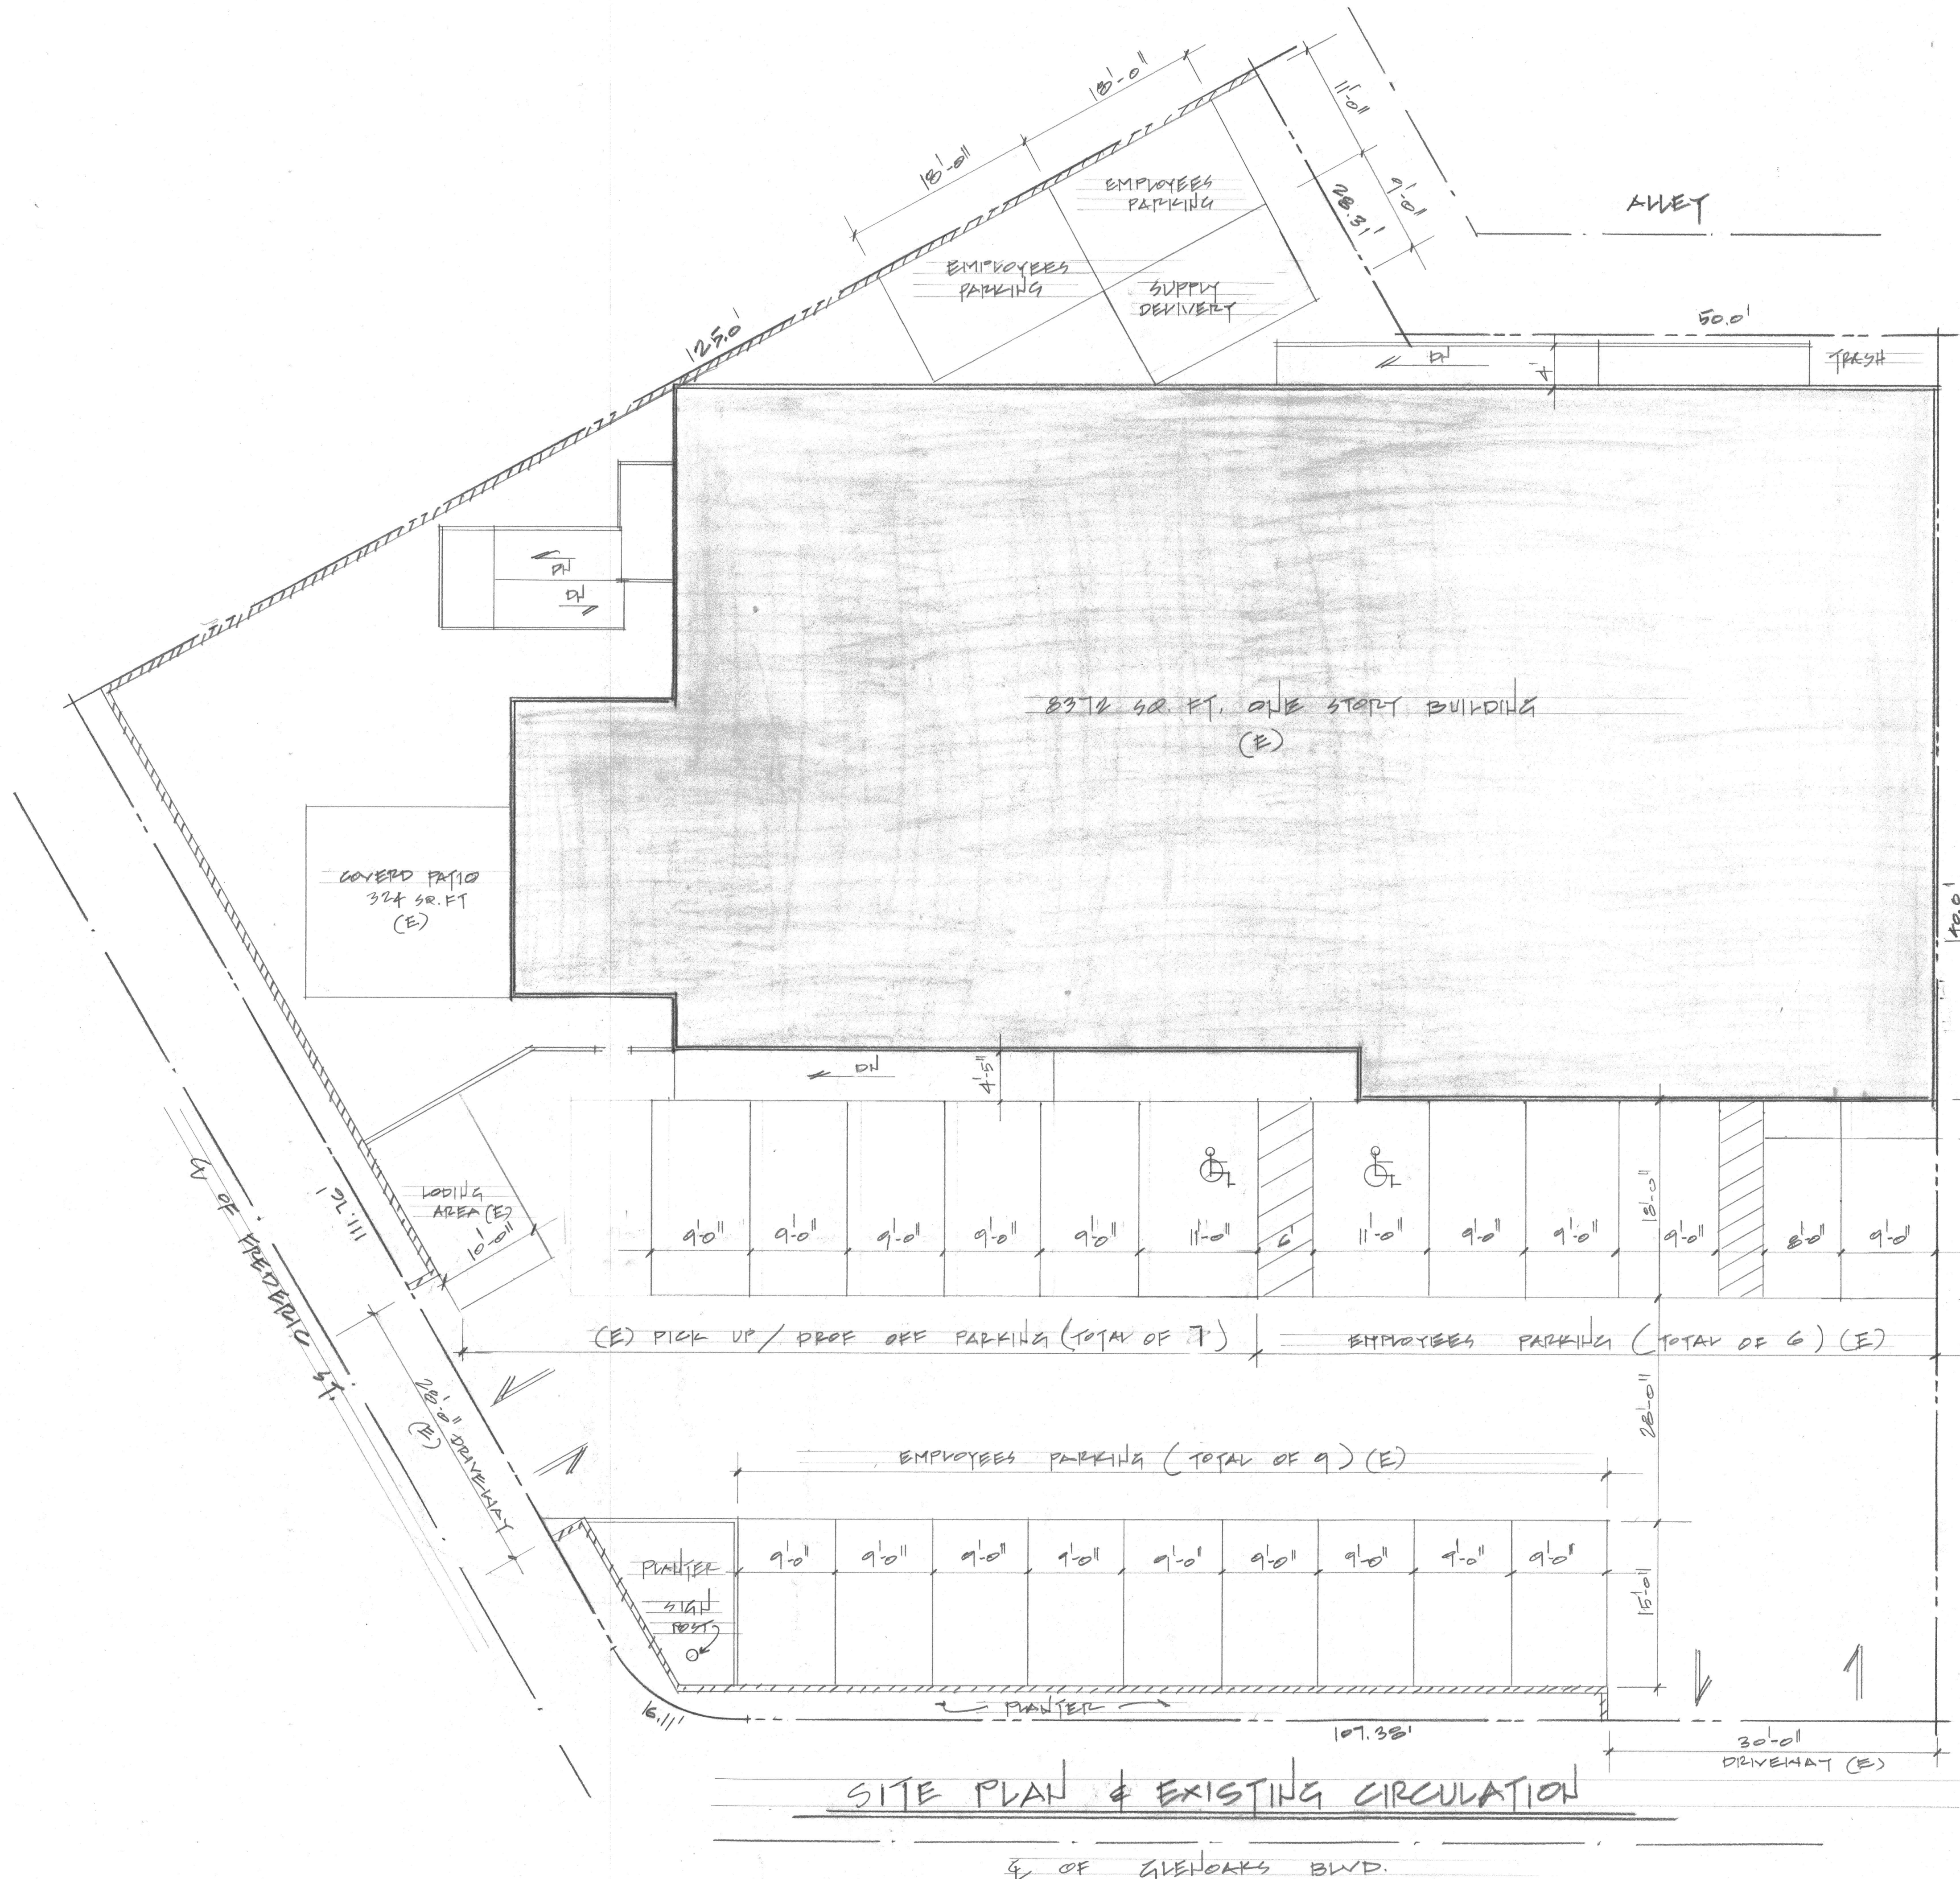

LEGAL DESCRIPTION
 LOT 20, 21
 TRACT # 14559
 LOT SIZE 21348.75 SQ. FT
 25' PARKING EXISTING


SITE PLAN & EXISTING CIRCULATION

of GLENDALES BLVD.

320 GLENDALES BLVD. BURBANK, CA.
 ADULT DAY HEALTH CARE CENTER

Date	01/05/22
Scale	1/8" = 1'-0"
Drawn	GL
Job	
Sheet	A-1
Of	Sheets

REVISIONS	BY

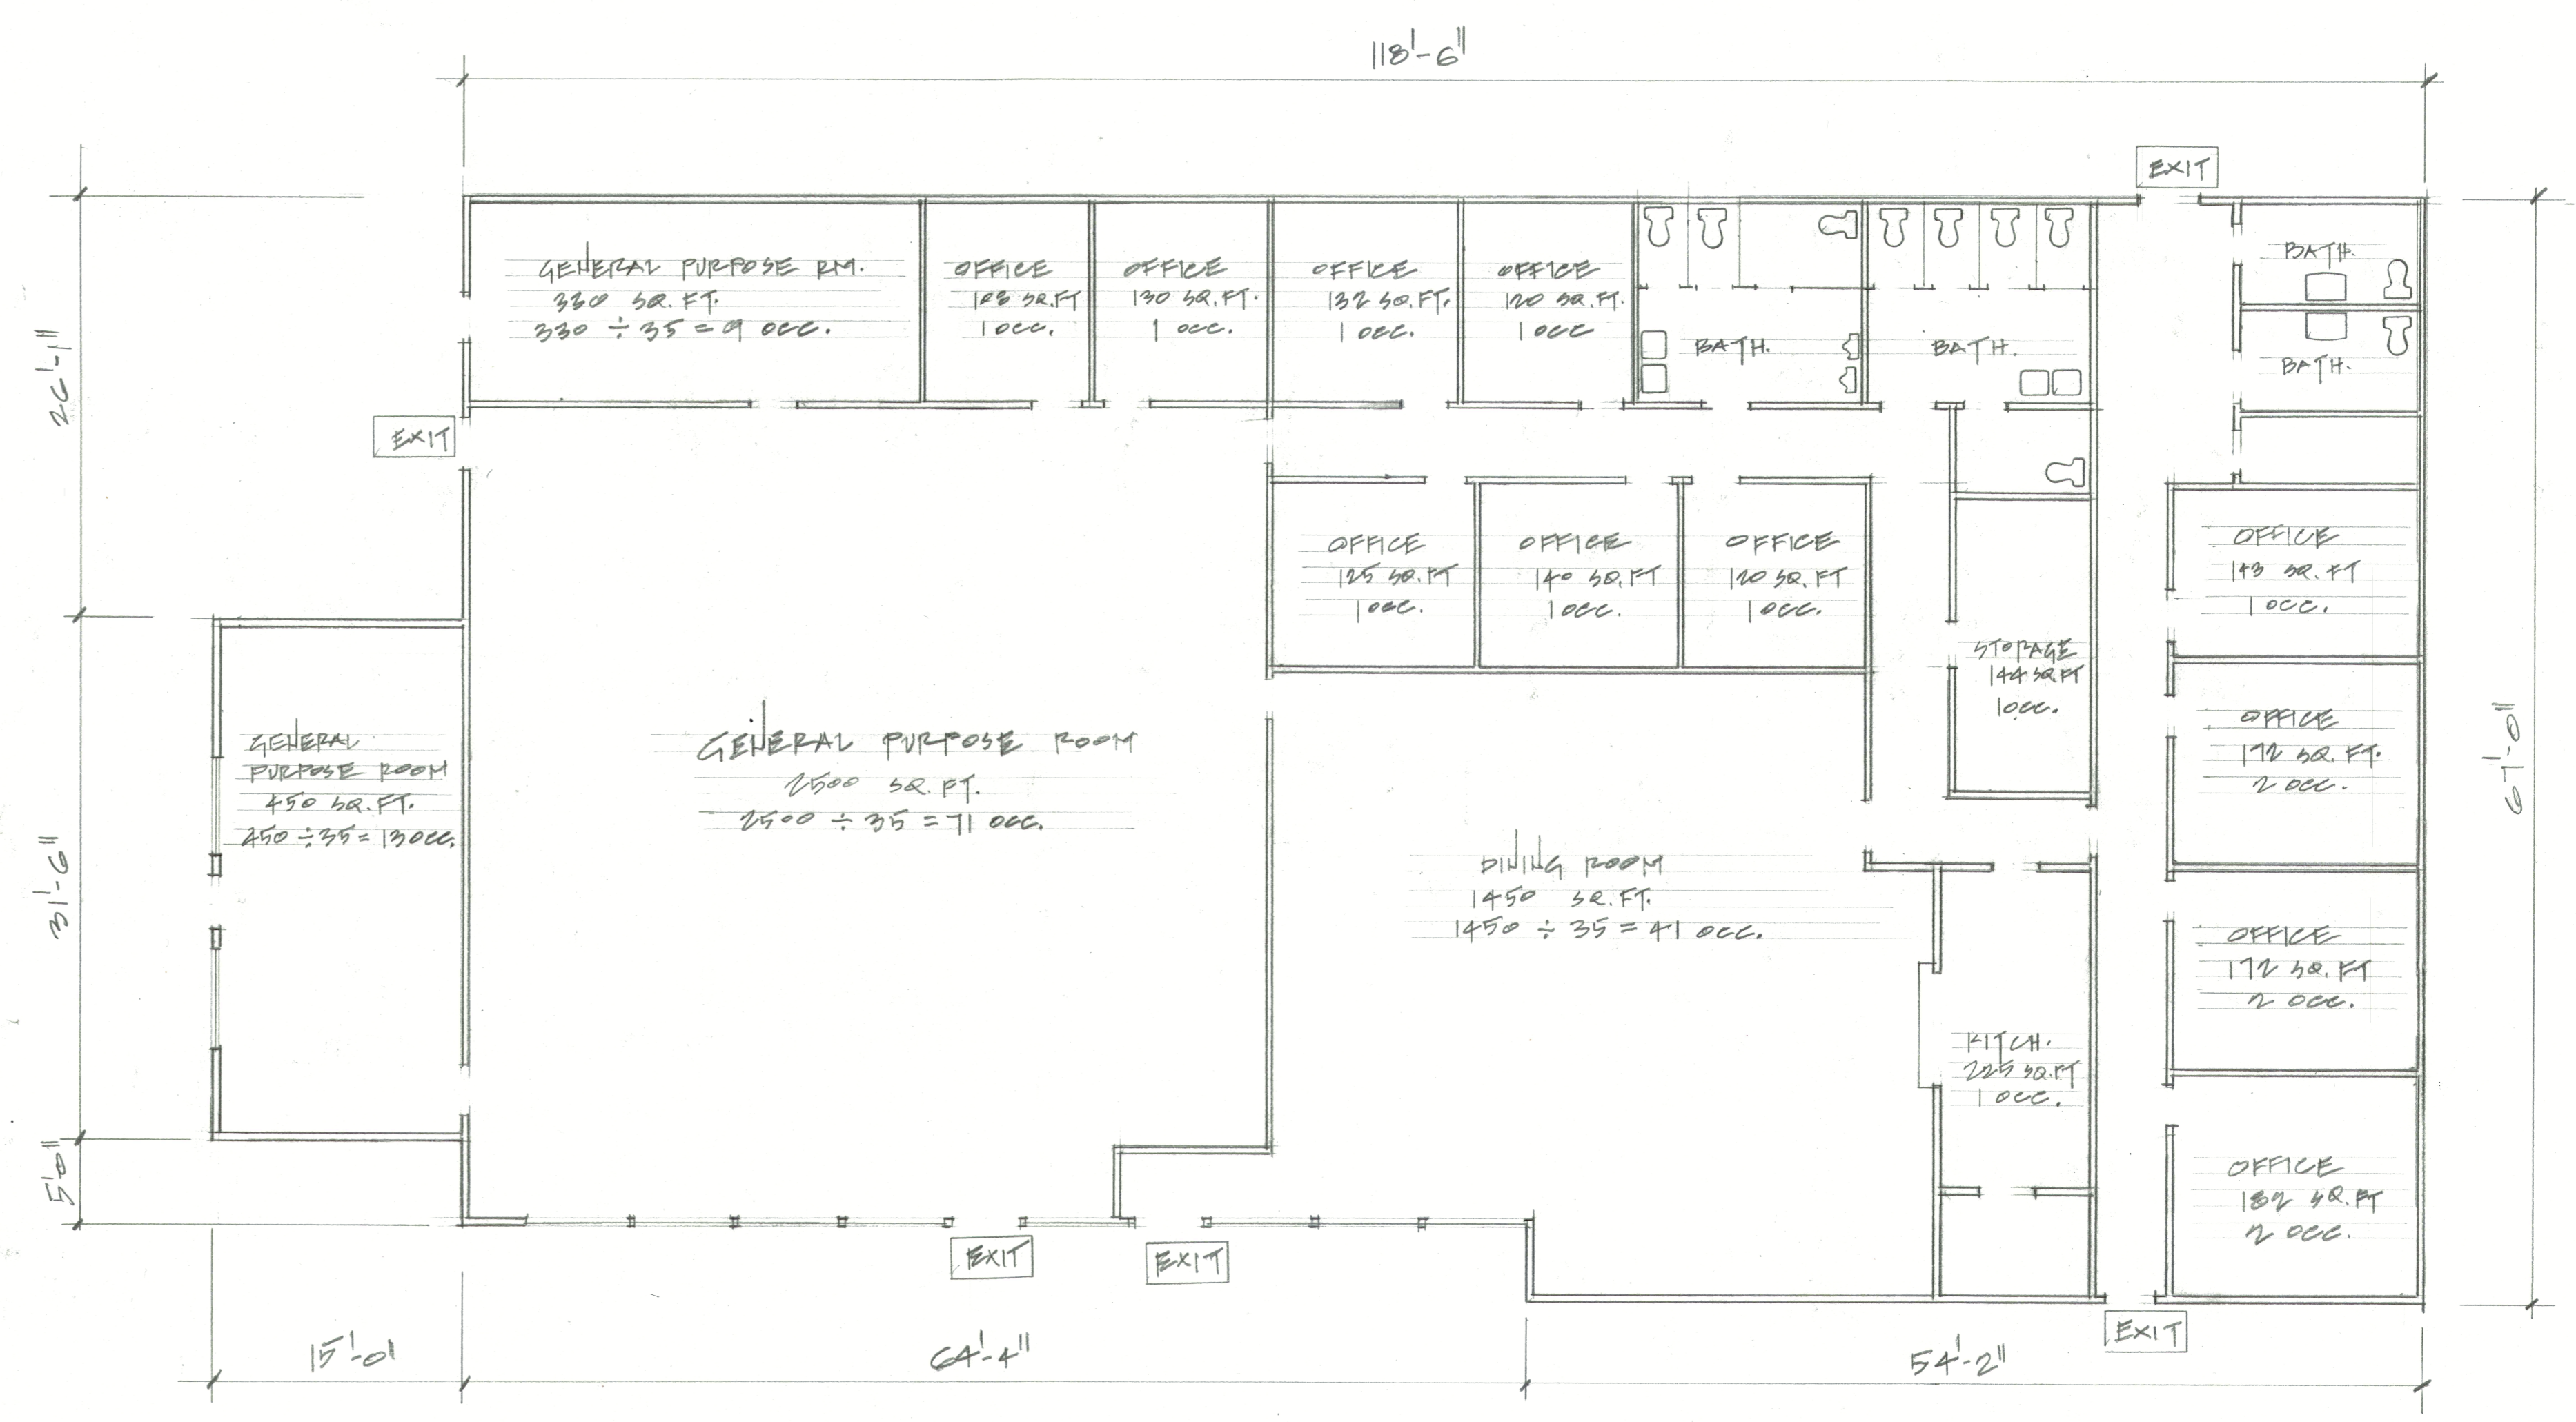

FLOOR PLAN (E)

OCCUPANCY LOAD (TABLE 1004.1.2)
I-4 OCCUPANCY

OCCUPANCY	AREA SQ. FT.	LOAD FACTOR	ACCUPANTS
Adult Day Care	4700	35	134
Office	1404	100	14
Kitchen	176	200	1
Storage	190	300	1
TOTAL OCCUPANCY			150

MIN PLUMBING FIXTURES PER.CPC 2016 TABLE 422.1
I-4 Occupancy

Plumbing Facilities	Male		Female	
	REQ'D	PROVIDED	REQ'D	PROVIDED
WC/U	4	4	5	6
LAV.	1	3	1	3
URINALS	0	2		

320 GLEDOAKS BL. BURBANK CA.
ADULT DAY CARE CENTER

Date	09/01/22
Scale	1/8" = 1'-0"
Drawn	JK
Job	
Sheet	A-2
Of	Sheets